


BATHROOM  
SUSPENDED CEILING  
HEIGHT = 3000mm

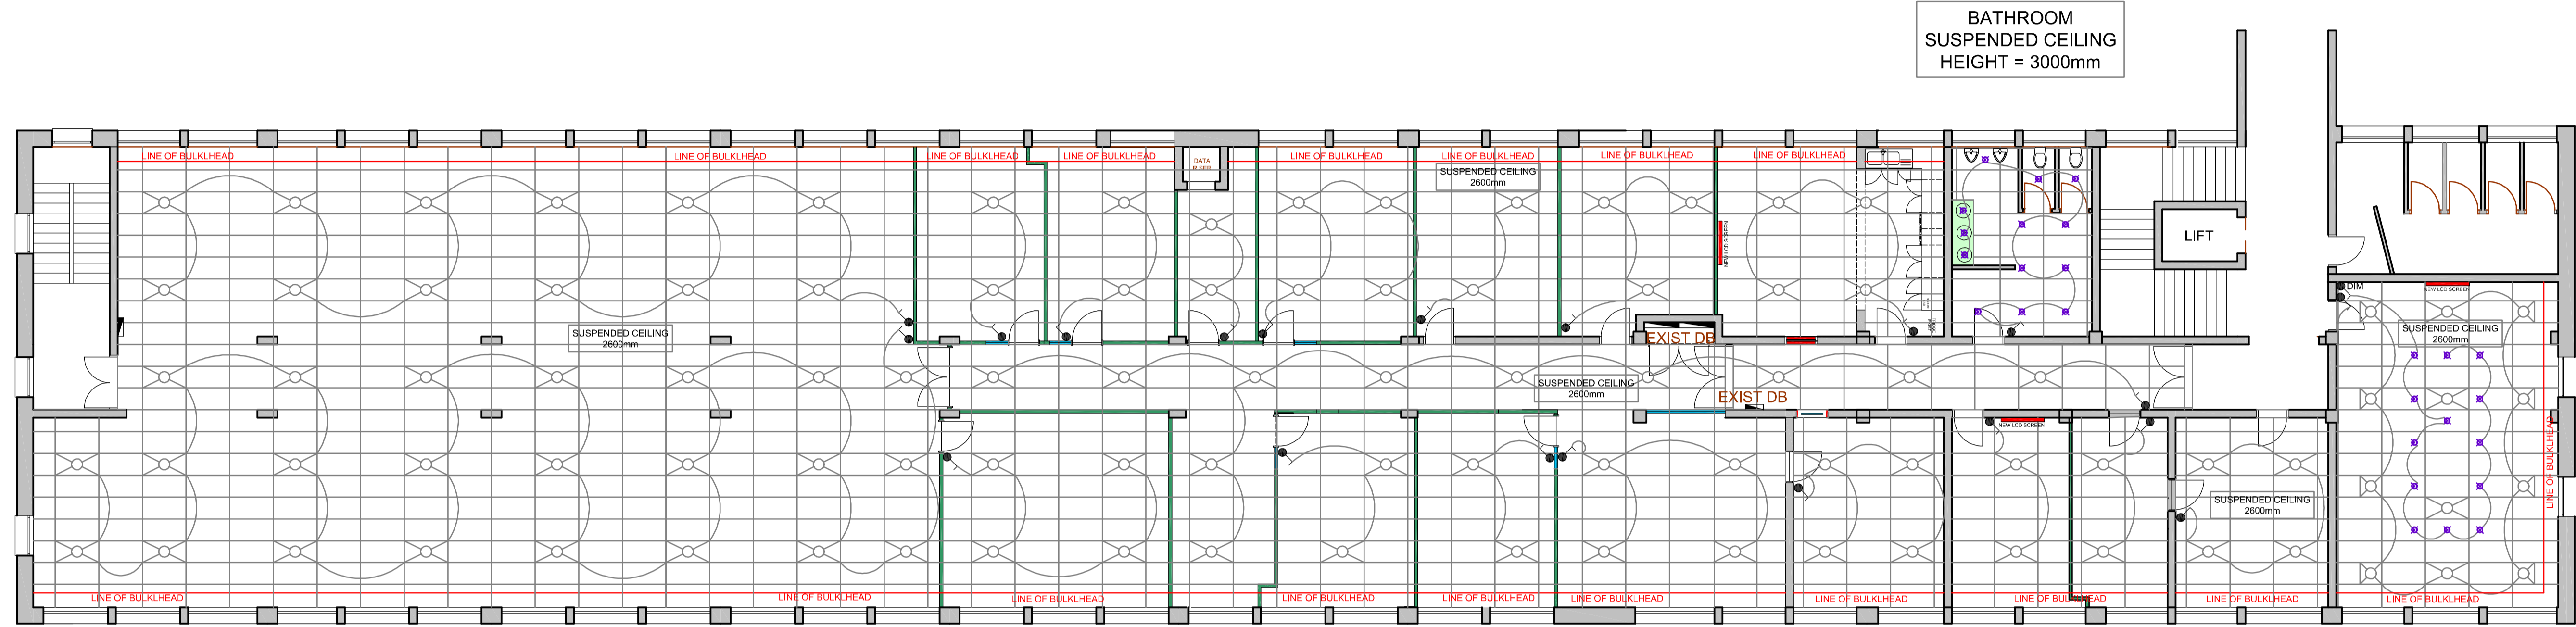


SUSPENDED CEILING  
2600mm

# BLOCK H

1ST FLOOR PLAN  
SCALE 1 : 100

CEILING BULKHEAD DETAIL  
SCALE 1:50

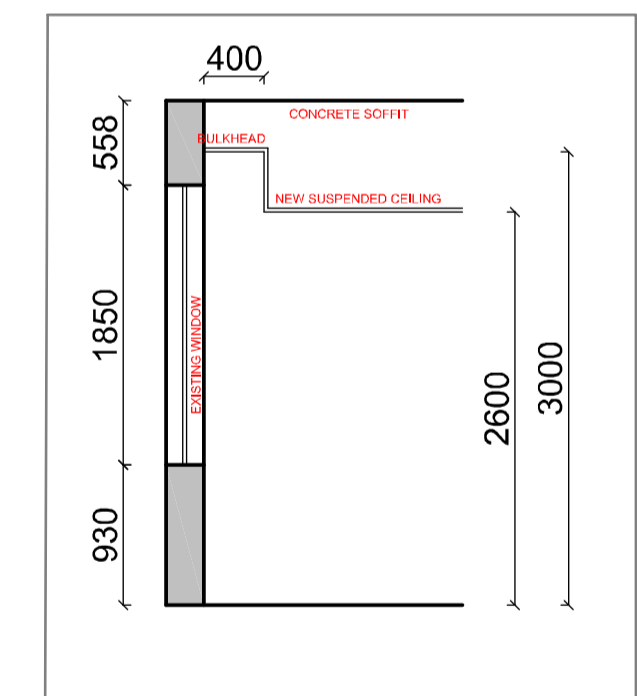

- NEW CEILING AND LIGHTING NOTES:**
- NEW RECESSED FLUORESCENT 1200 X 600 LIGHT FITTING
  - NEW RECESSED FLUORESCENT 600 X 600 LIGHT FITTING
  - NEW WHITE SUSPENDED CEILING GRID WITH SHADOWLINE AND VINYL PANELS 1200 X 600mm SEE TENDER DOC SPECIFICATIONS
  - NEW LIGHT SWITCH
  - NEW LIGHT SWITCH WITH DIMMER FUNCTION
  - NEW DOWN LIGHTER RADIANT A220 IN SATIN CHROME FINISH WITH LED LAMP
- NEW SUSPENDED CEILING HEIGHT = 2600mm

KEY TO SYMBOLS:	
	EXISTING BRICK WALLS
	EXISTING PARTITION WALLS
	NEW DRY WALL UP TO CEILING HEIGHT OF 2600mm
	EXISTING WALLS TO BE DEMOLISHED
	RE-INSTALL EXISTING STANDARD HEIGHT DOOR 2000 IN ALU FRAME
	NEW GLASS & ALU DOUBLE DOOR 2600mm IN ALU FRAME WITH H/DUTY DOOR CLOSER
	NEW WINDOW IN ALU FRAME 2000H X 600W WITH 600mm HIGH VINYL STRIP
	NEW WINDOW IN ALU FRAME 2600H X 2175W WITH 600mm HIGH VINYL STRIP
	DOUBLE SWITCH SOCKET 16 AMP
	SINGLE SWITCH SOCKET 16 AMP
	SINGLE SWITCH SOCKET 16 AMP INSTALLED IN CEILING VOID
	SINGLE RED DEDICATED SWITCH SOCKET 16 AMP
	DOUBLE RED DEDICATED SWITCH SOCKET 16 AMP
	SINGLE RED DEDICATED SWITCH SOCKET 16 AMP INSTALLED IN CEILING VOID
	EXIST 3-CHANNEL P/SKIRTING TO BE REMOVED
	EXIST 3-CHANNEL P/SKIRTING INSTALLED AT GROUND LEVEL
	NEW ISOLATOR
	POP-UP IN DESK CONSISTS OF: 2 X NORMAL (WHITE) PLUGS 2 X DEDICATED (RED) PLUGS 1 X DATA POINT 1 X 2-PIN EURO PLUG
	DATA POINT
	BIOMETRIC READER

FLOOR FINISHES:	
	NEW FULL CARPET SERENGETI, COLOUR - BLACK WITH BITUMEN BACK
	NEW CARPET TILES NEXUS BELGOTEX NEXBAC B/BERPOINT 920 WITH BITUMEN BACK. COLOUR: MINK BORDER 500mm WIDE
	NEW CARPET TILES NEXUS BELGOTEX NEXBAC B/BERPOINT 920 WITH BITUMEN BACK. COLOUR: MALI
	NEW PORCELAIN FLOOR TILES SIZE 500 X 500mm COLOUR: BEIGE

WALL FINISHES:	
	MERANTI DADO RAIL STAINED MAHOGANY, INSTALLED 850mm AFFL
	PLASCON CASHMERE INTERIOR ABOVE RAIL - IVORY WHITE Y4-B2-3 BELOW RAIL - CITY FOG GR-NO1
	PLASCON CASHMERE INTERIOR IVORY WHITE Y4-B2-3
	CERAMIC WALL TILES 600 X 600 SEE DETAIL LAYOUTS
	25mm PERFORATED NATURAL ALUMINIUM VENETIAN BLIND

NOTES:  
EXISTING WINDOW FRAMES TO BE PAINTED WHITE. INSIDE AND OUTSIDE

**GENERAL NOTES:**

PLEASE TAKE NOTE THAT THESE PLANS MUST BE READ IN CONJUNCTION WITH THE GPAA TENDER DOCUMENT

**GENERAL NOTES:**

CONTRACTORS AND SUB-CONTRACTORS ARE TO CHECK ALL DIMENSIONS AND LEVELS ON SITE BEFORE COMMENCING WITH WORK OR CUTTING OF MATERIALS

WRITTEN DIMENSIONS TAKE PREFERENCE OVER SCALED DIMENSIONS

GPAA IS TO BE NOTIFIED OF ANY VARIATIONS TO THIS PLAN PRIOR TO COMMENCEMENT OF WORK

THIS DRAWING IS THE COPYRIGHT OF GPAA AND MAY NOT BE USED FOR ANY PURPOSE WHATSOEVER WITHOUT WRITTEN APPROVAL FROM GPAA

ALL WORK TO COMPLY WITH THE BUILDING REGULATIONS SANS 10400 AND APPROVED MUNICIPAL BYLAWS

**the gpaa**  
Department: Government Pensions Administration Agency  
REPUBLIC OF SOUTH AFRICA

Project: **BLOCK H 1ST FLOOR HR NEW LAYOUT**

Drawing Title: **CEILING AND LIGHTING LAYOUT**

Date:	Drawn by:	Scale:
2014/02/03	SR	1:100 ON A1
Project Number:	Rev no.:	Drawing Number:
GPAA-15	2	07-02

## HR - PROPOSED NEW LAYOUT